

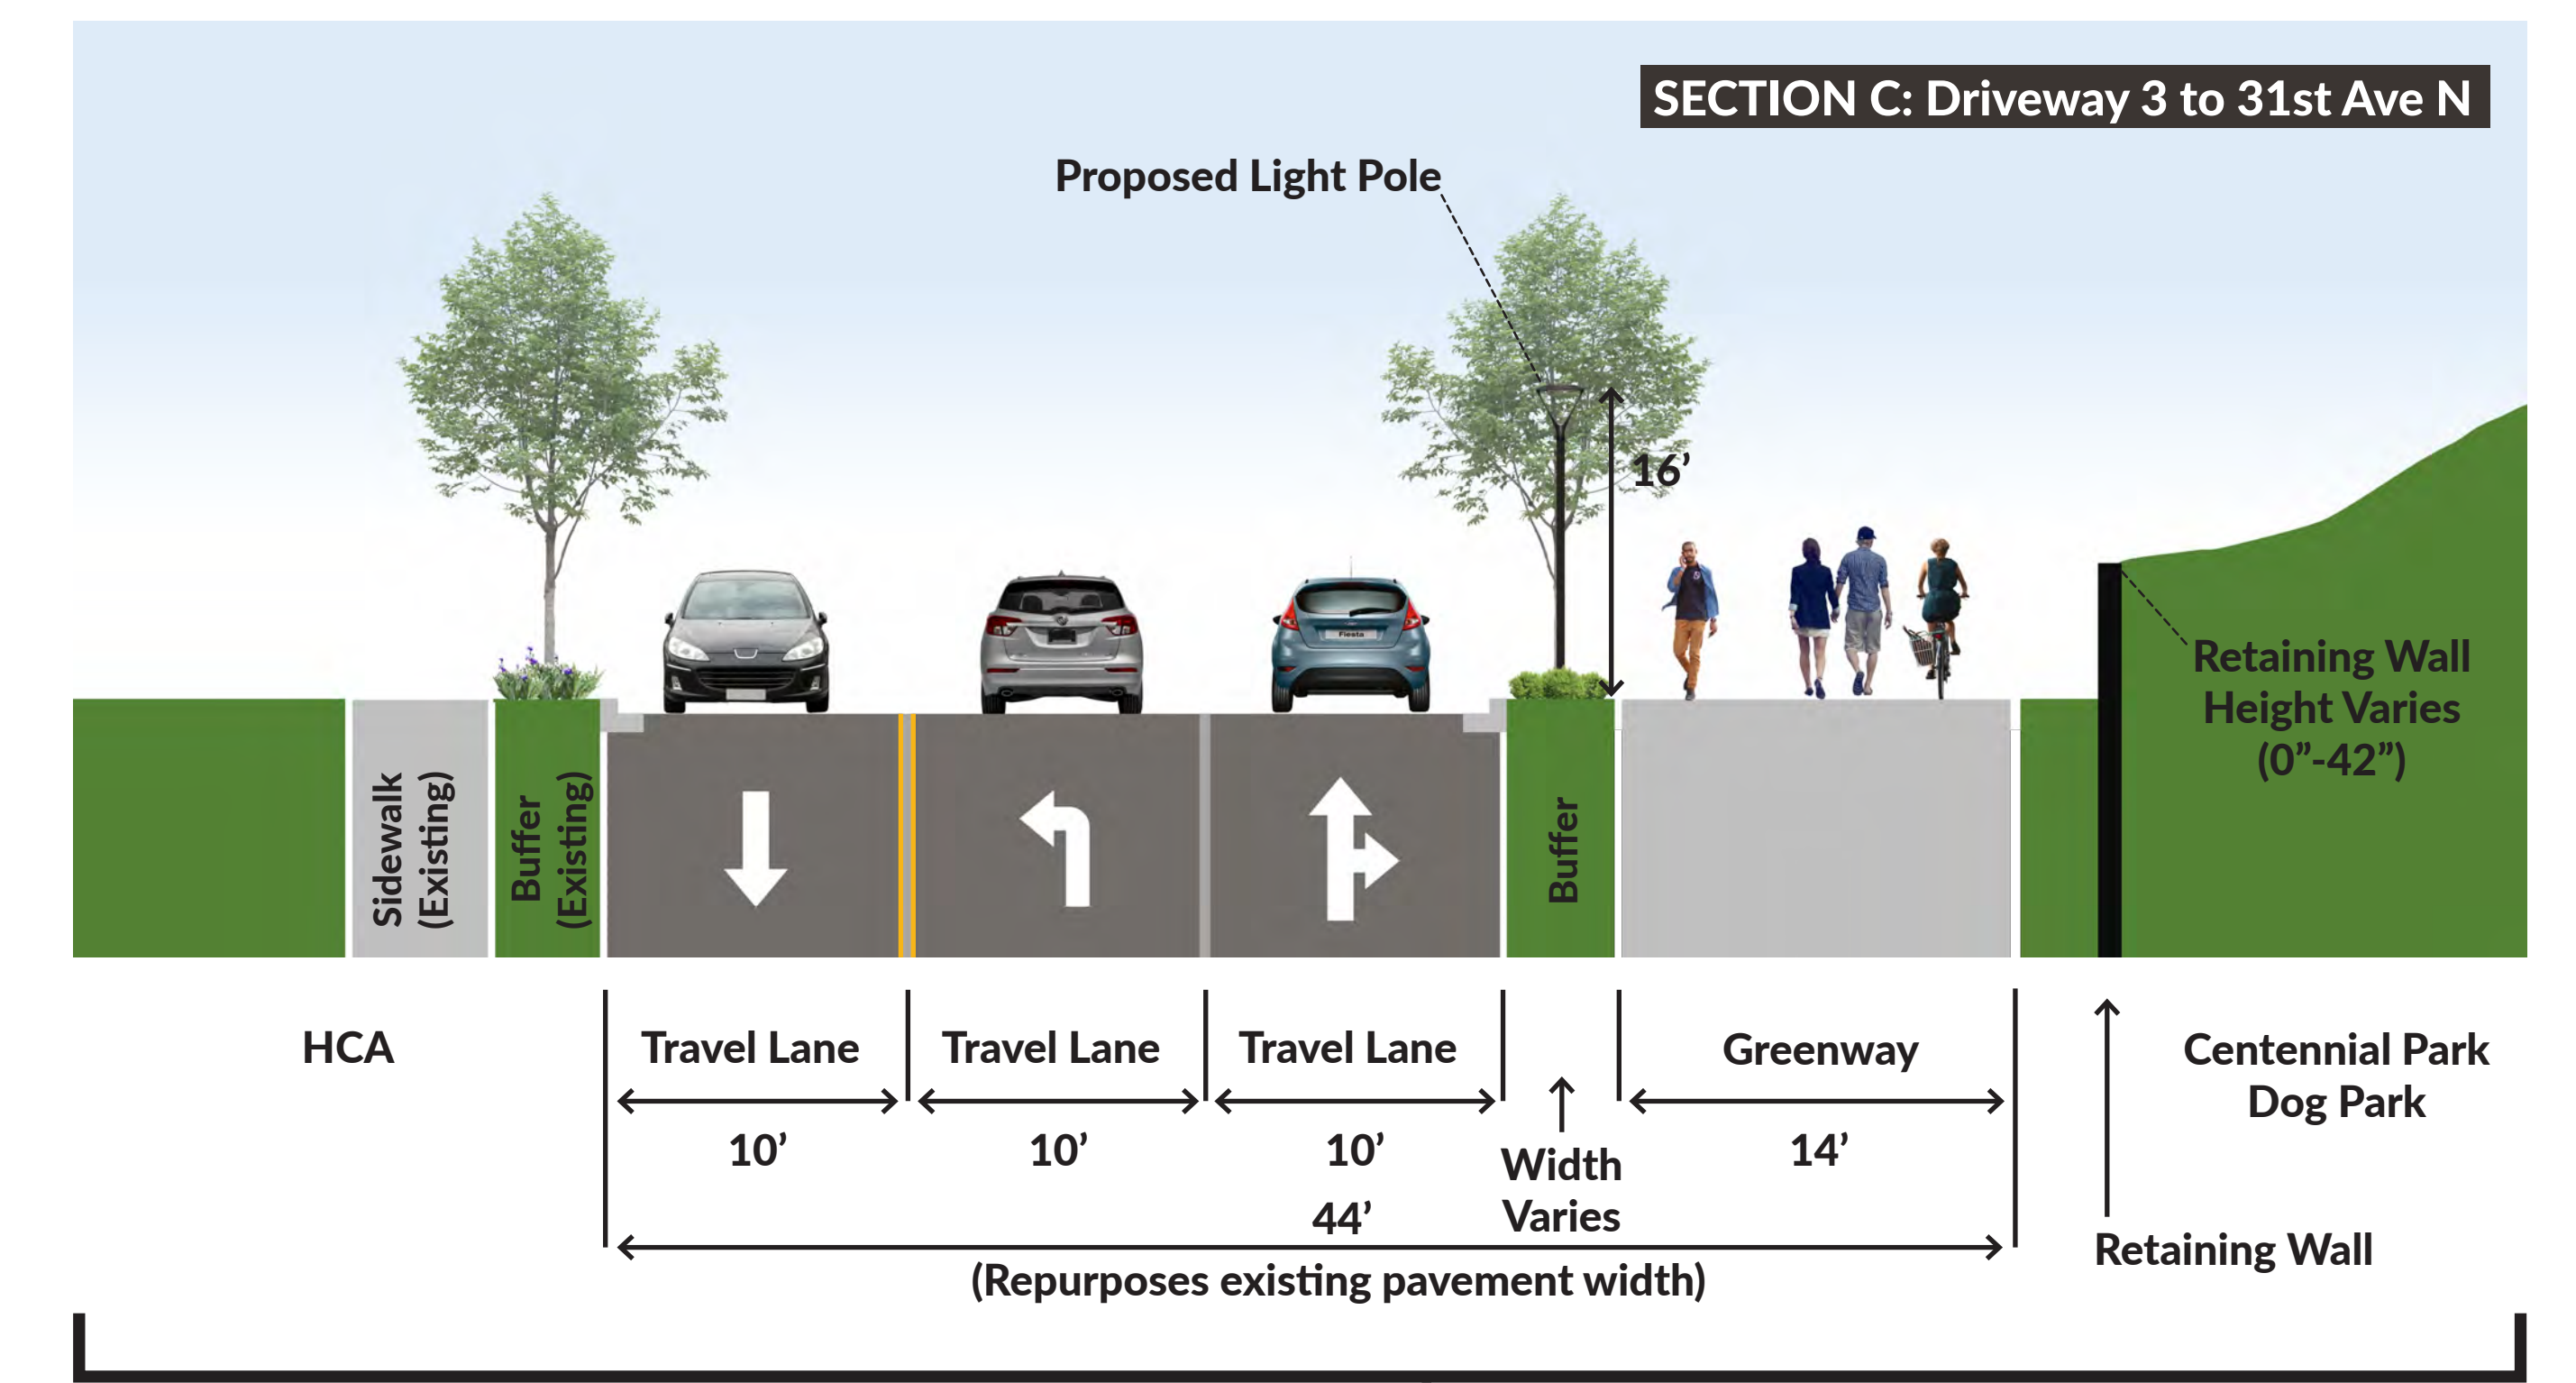



CROSS SECTION A VIEW

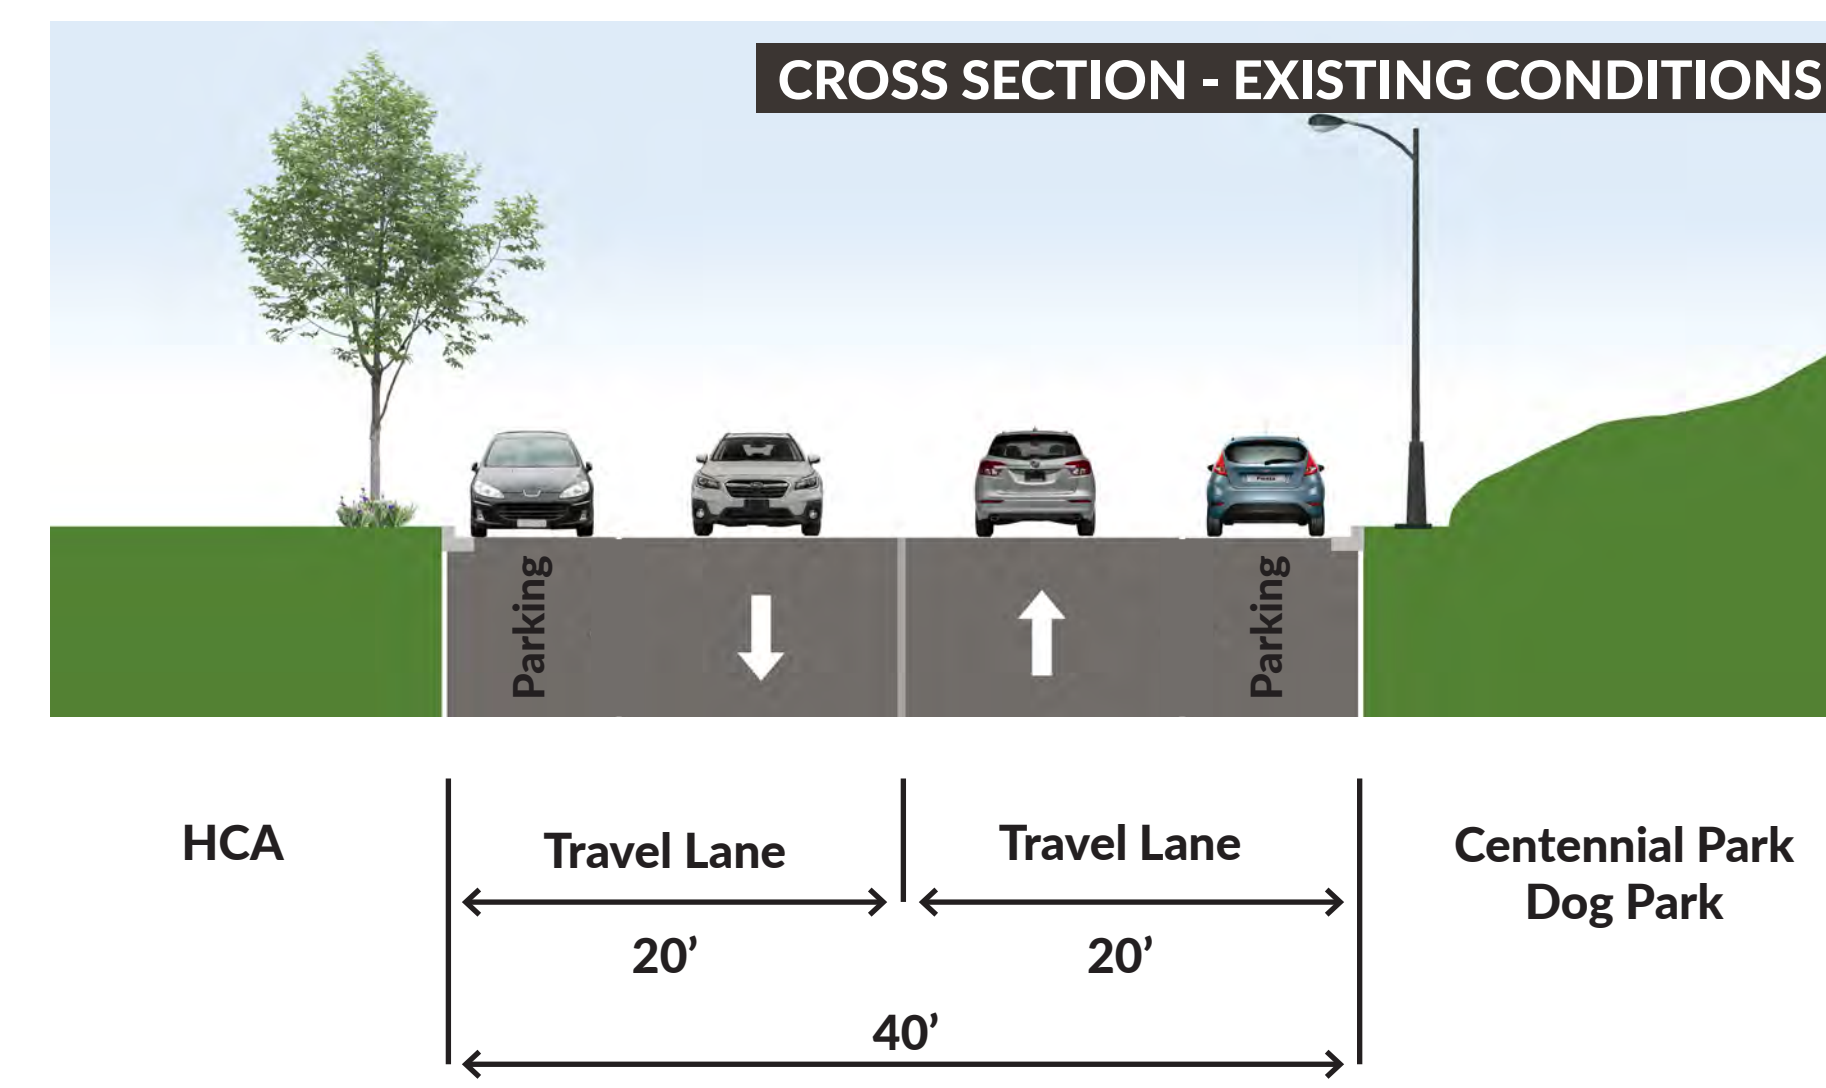

CROSS SECTION C VIEW



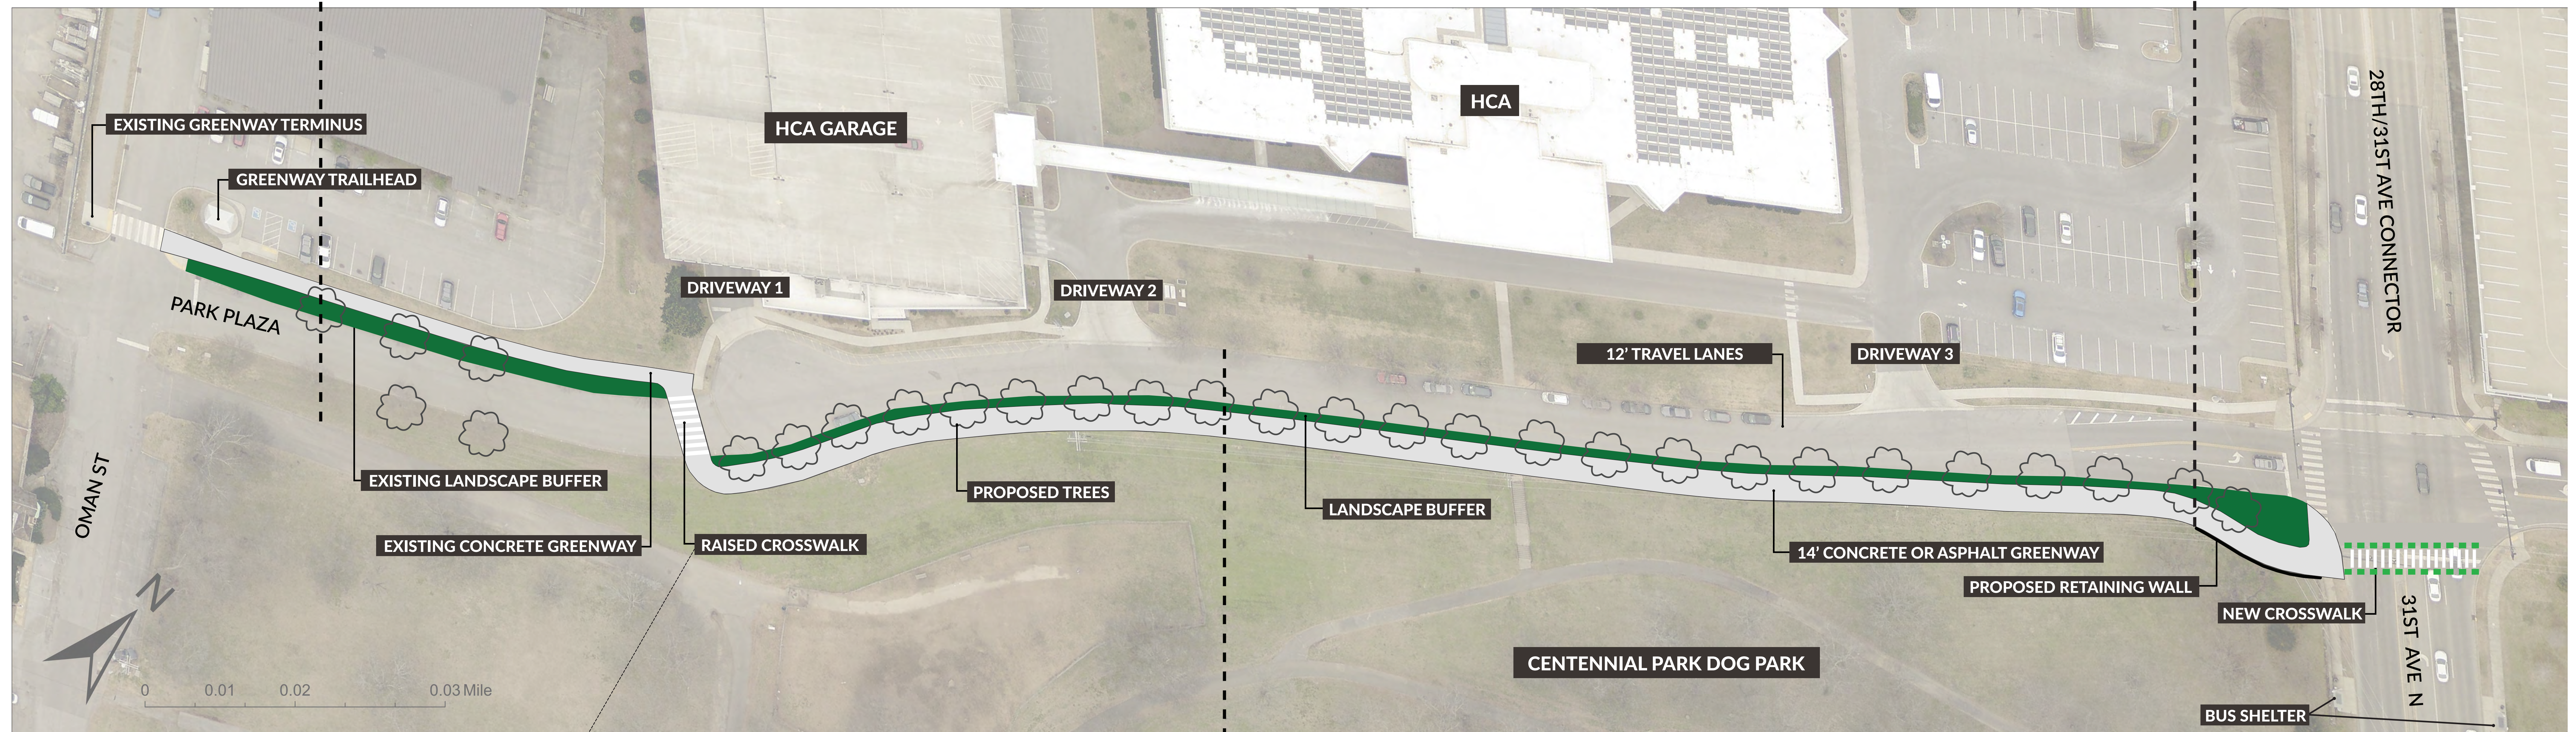


CROSS SECTION B VIEW

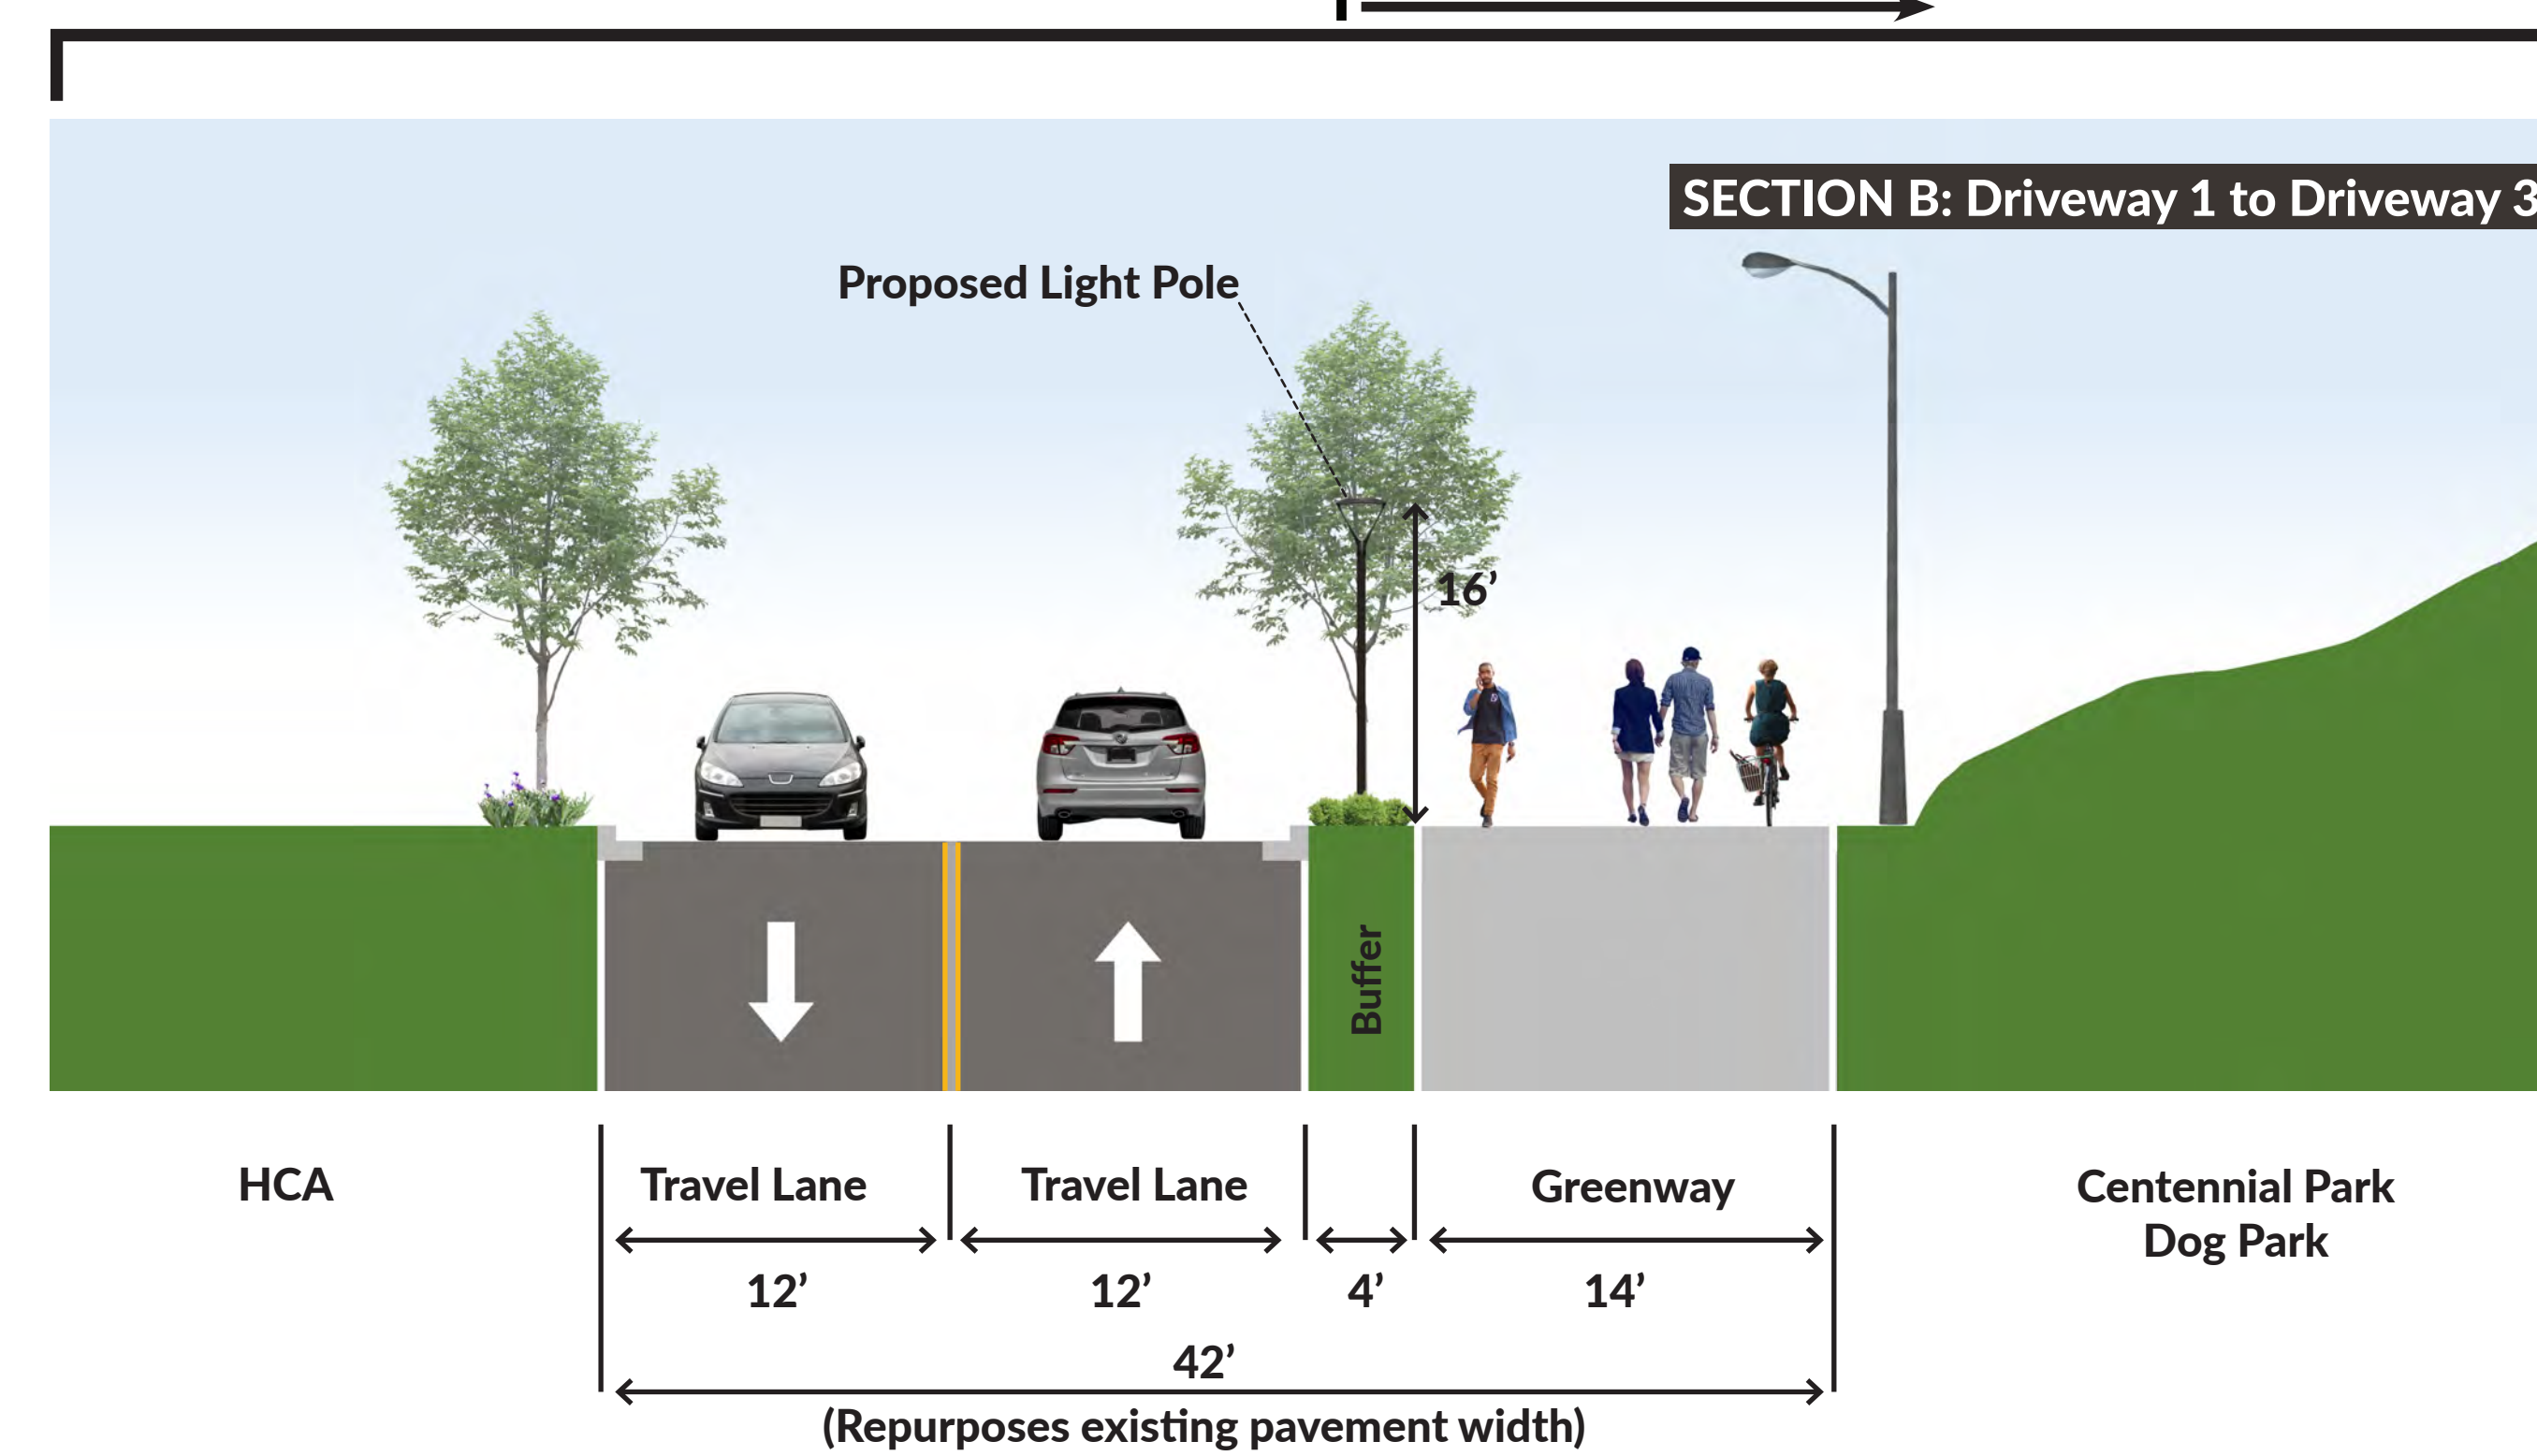

440 Greenway - Park Plaza to Centennial Park

Design (Not to Scale)

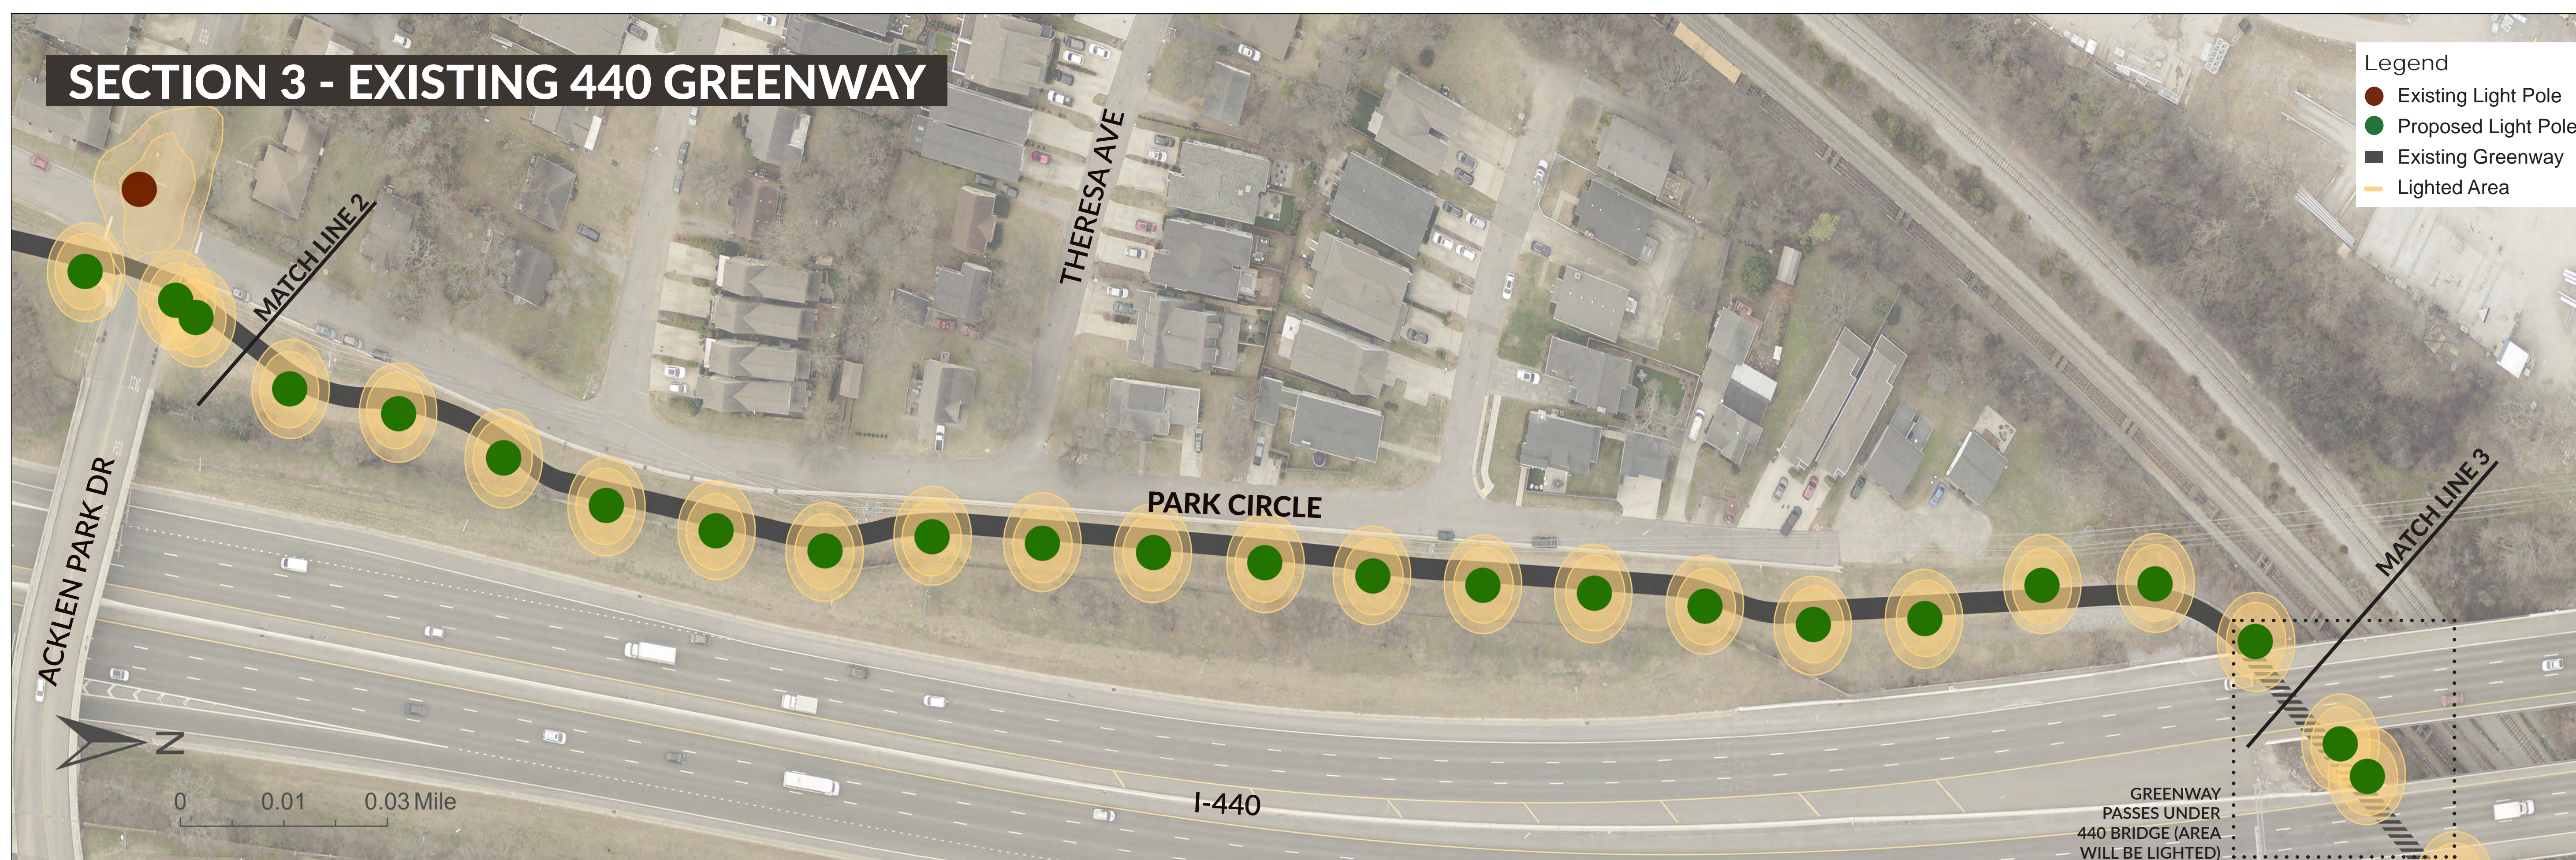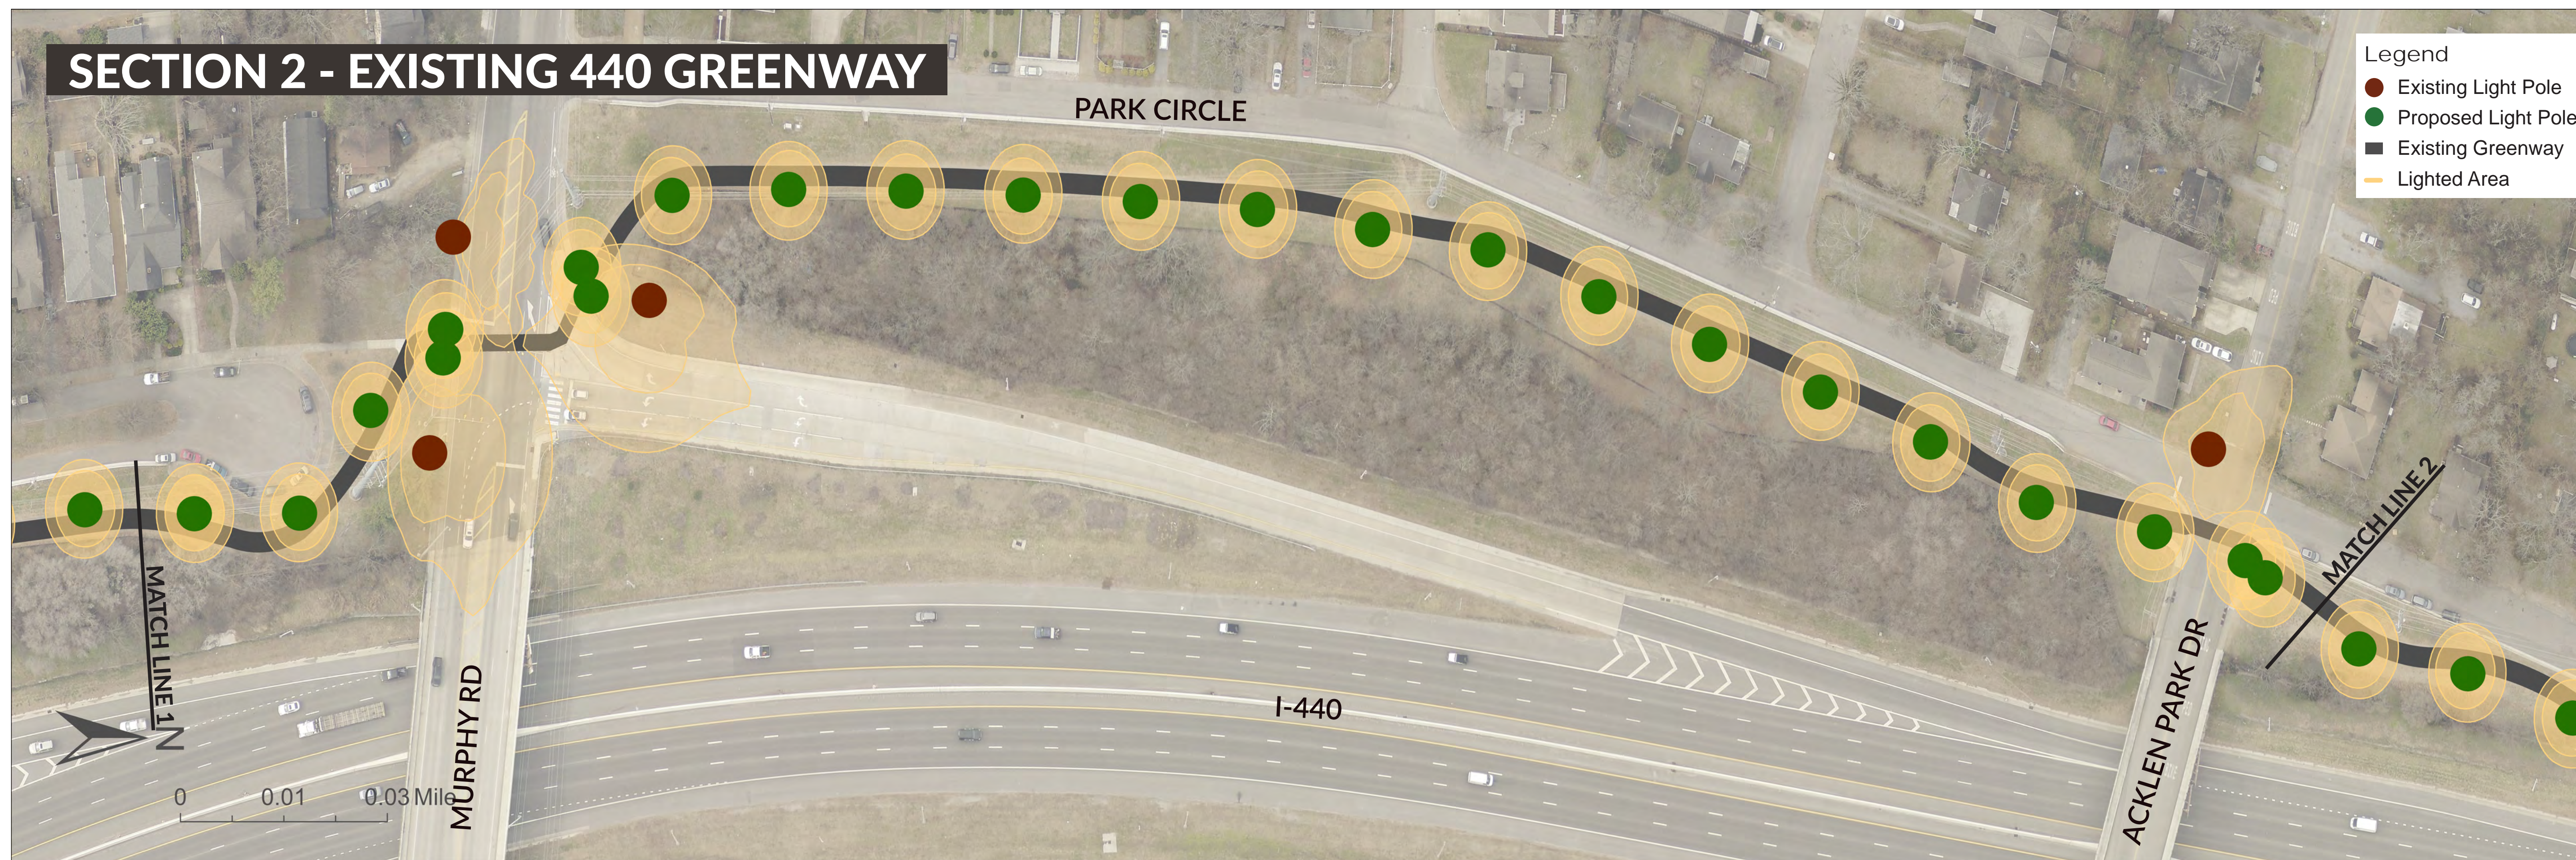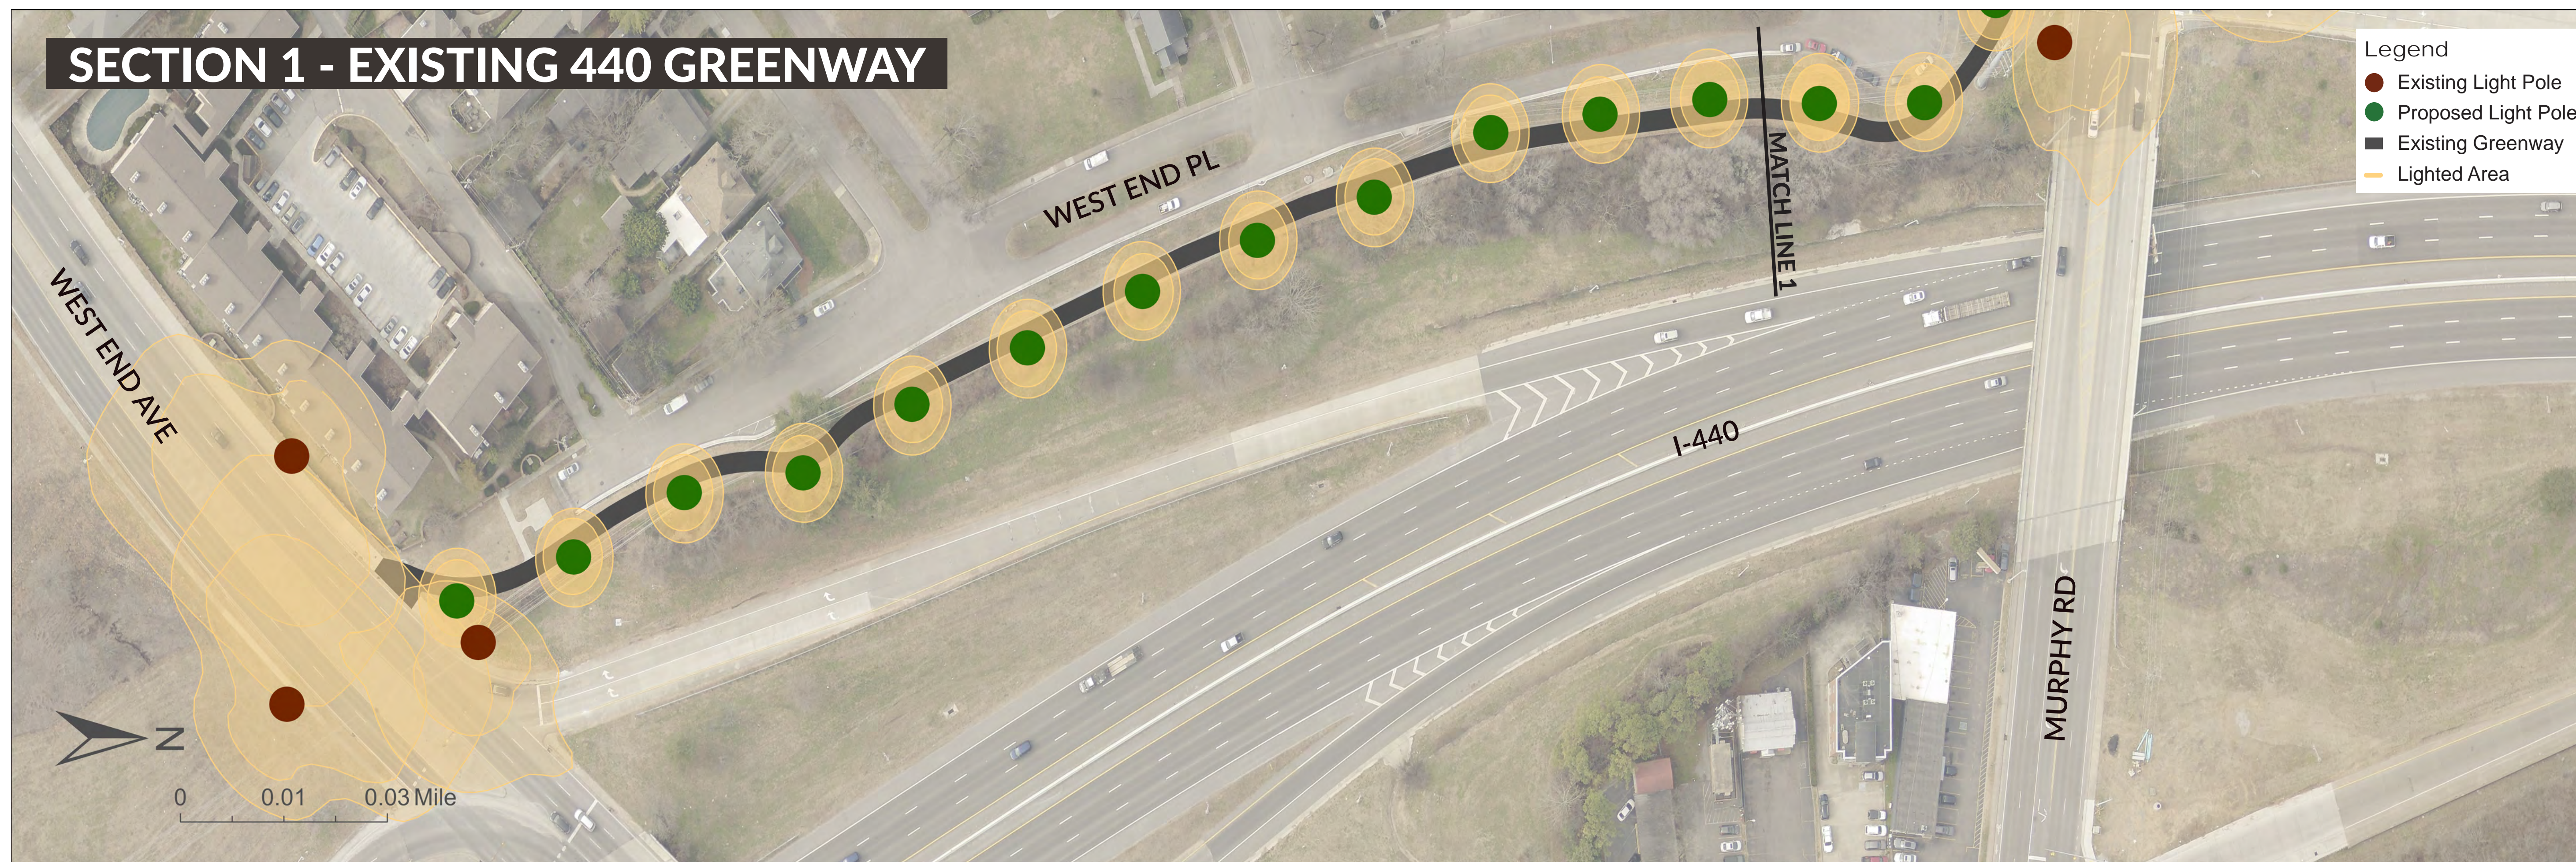


440 Greenway - West End Avenue to Centennial Park


Lighting Plans (Not to Scale)




SECTION 4 - EXISTING & PROPOSED 440 GREENWAY

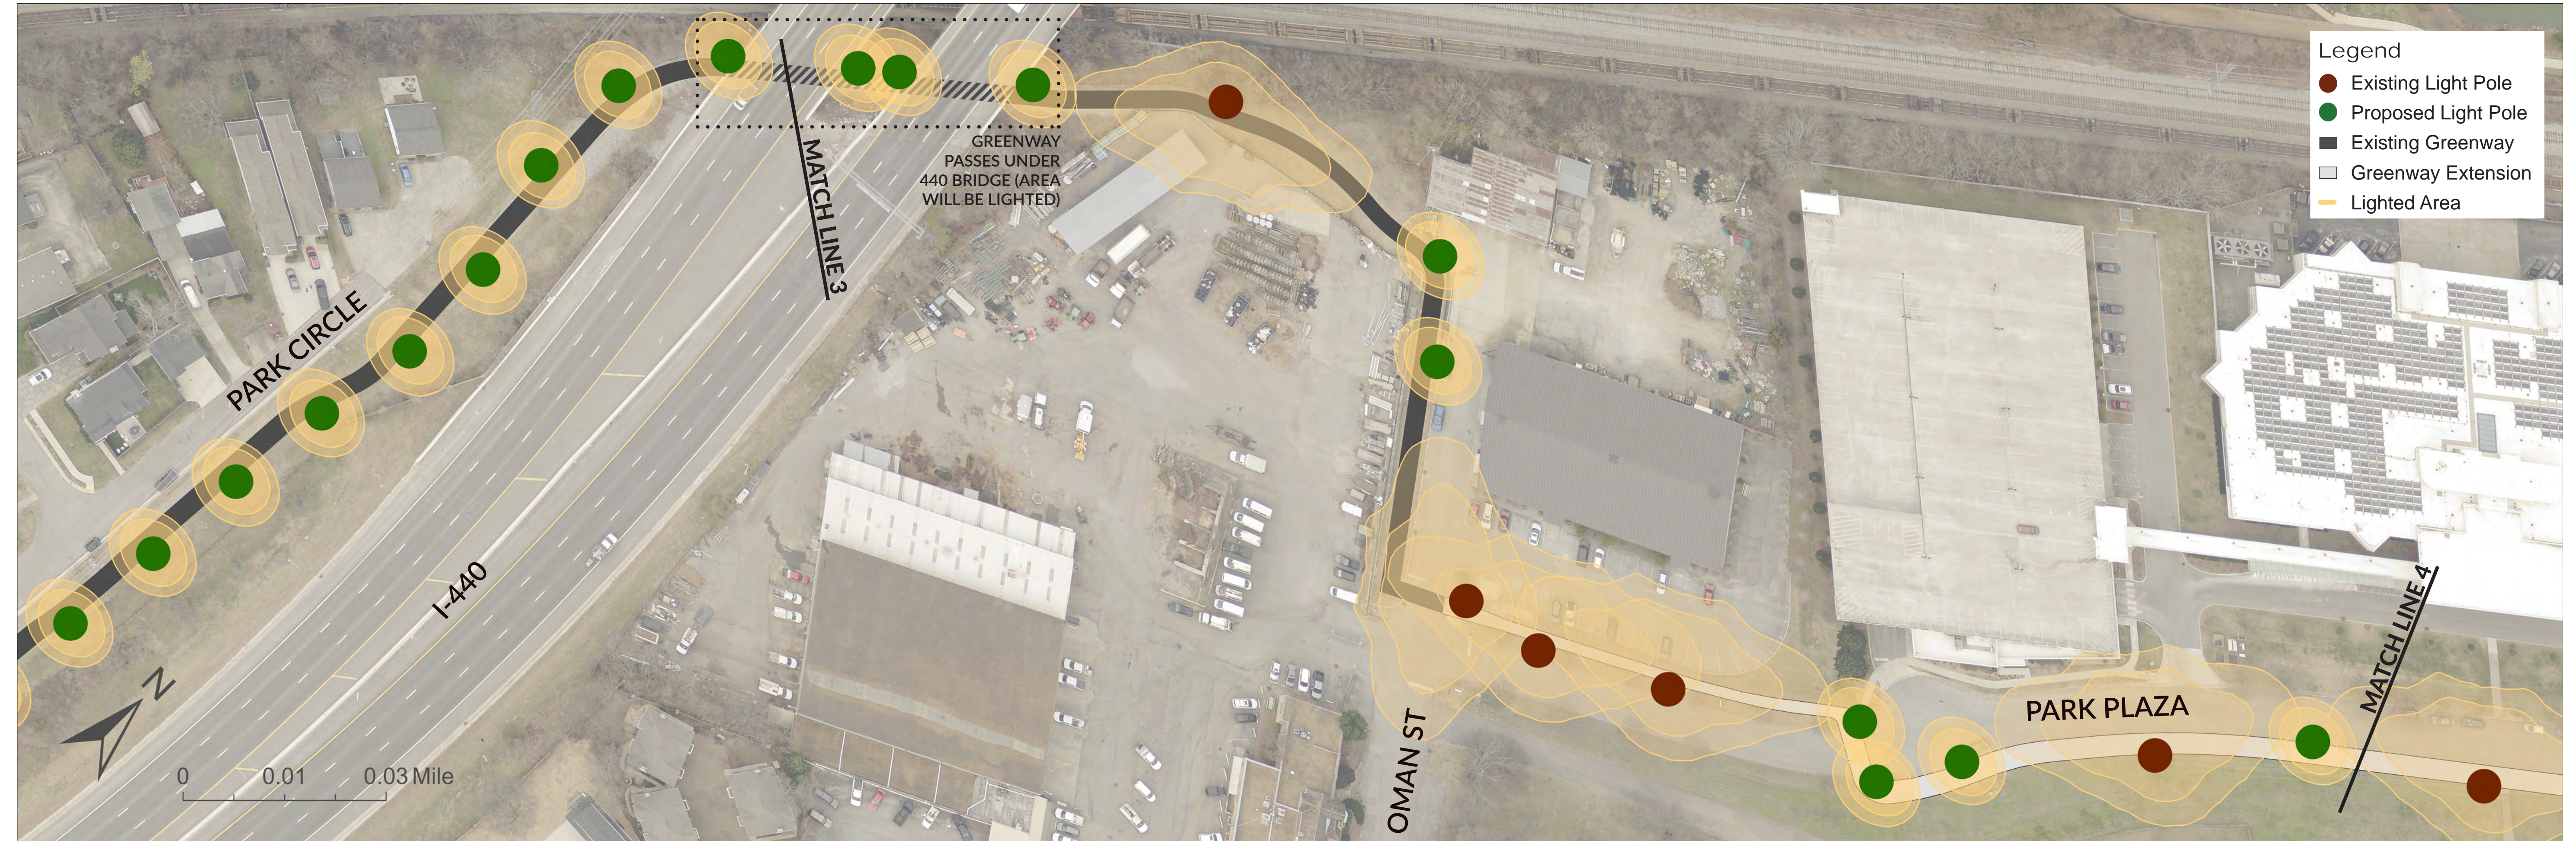


SECTION 5 - EXISTING & PROPOSED 440 GREENWAY

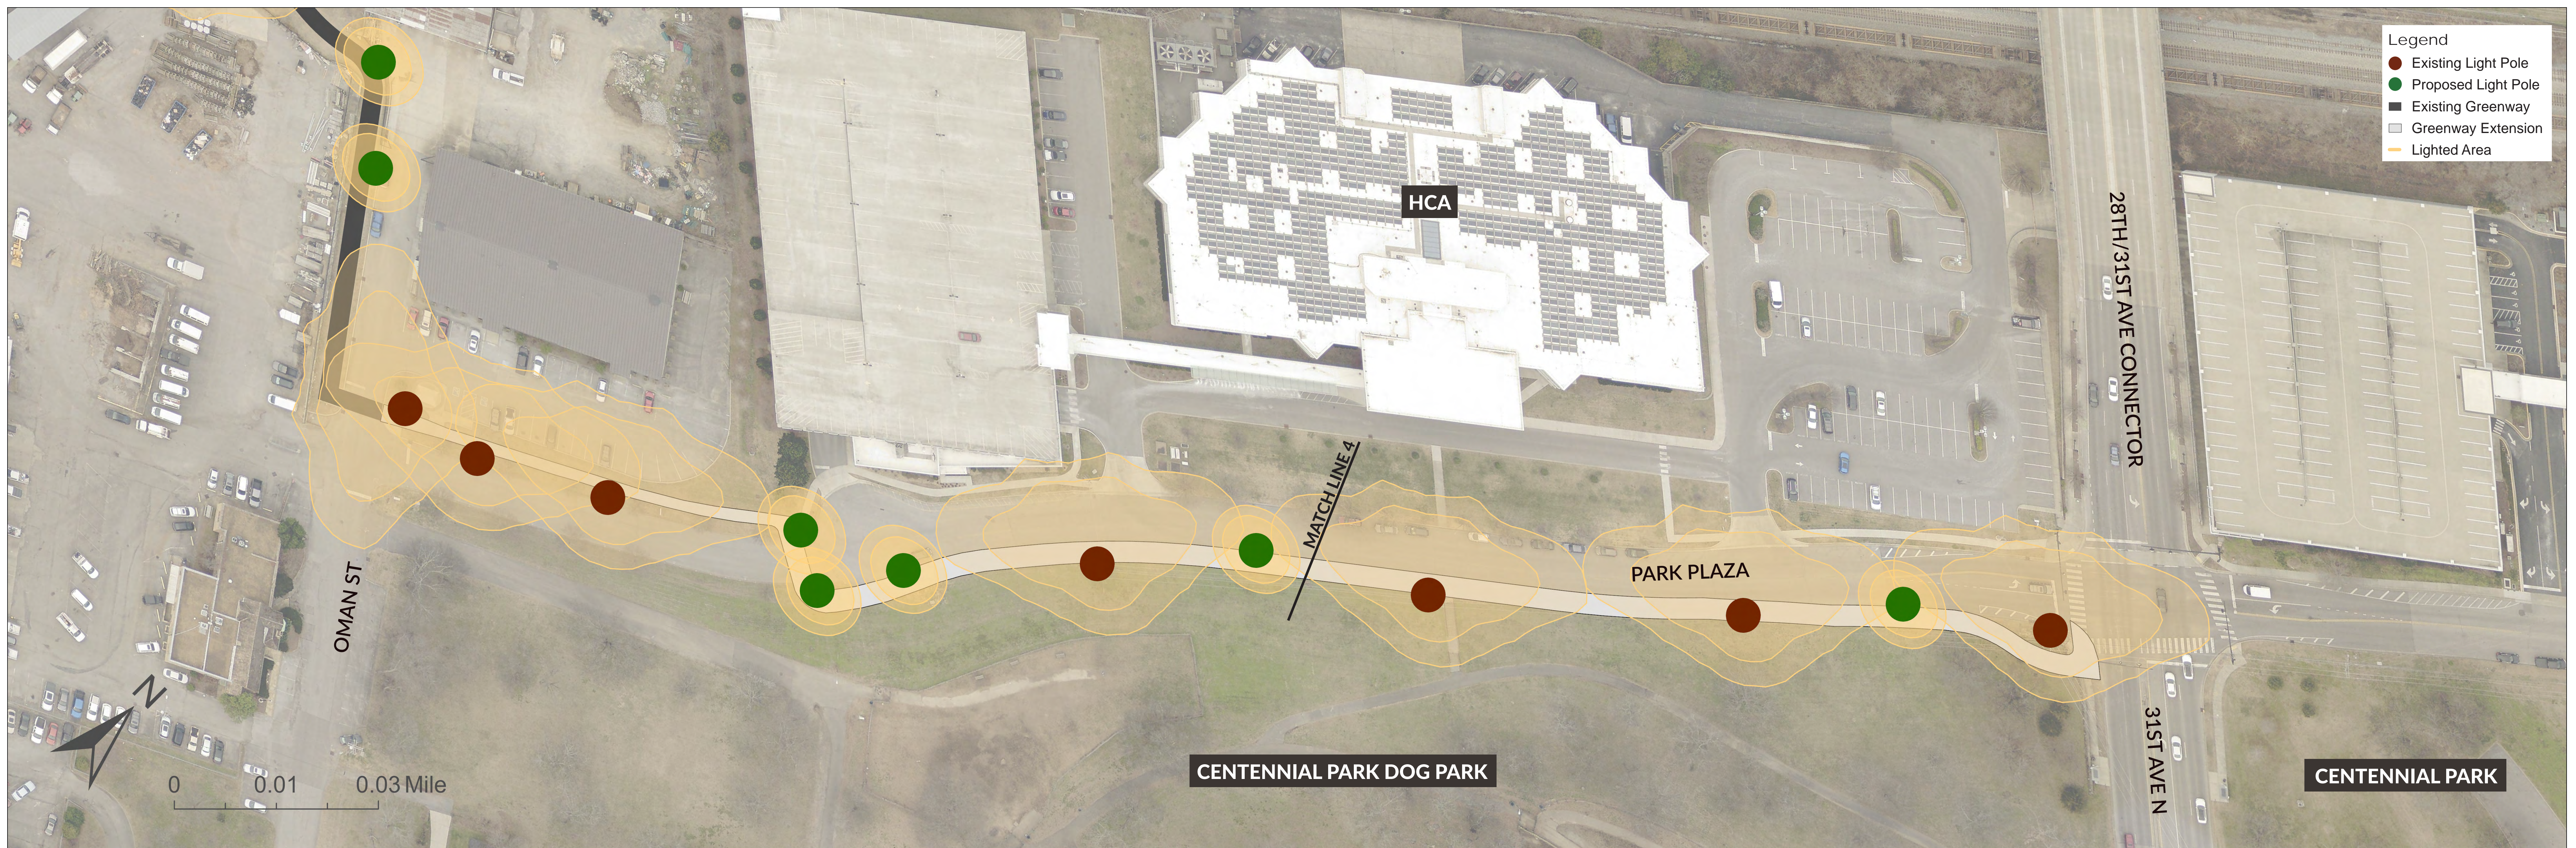


440 Greenway - West End Avenue to Centennial Park
Lighting Plans (Not to Scale)

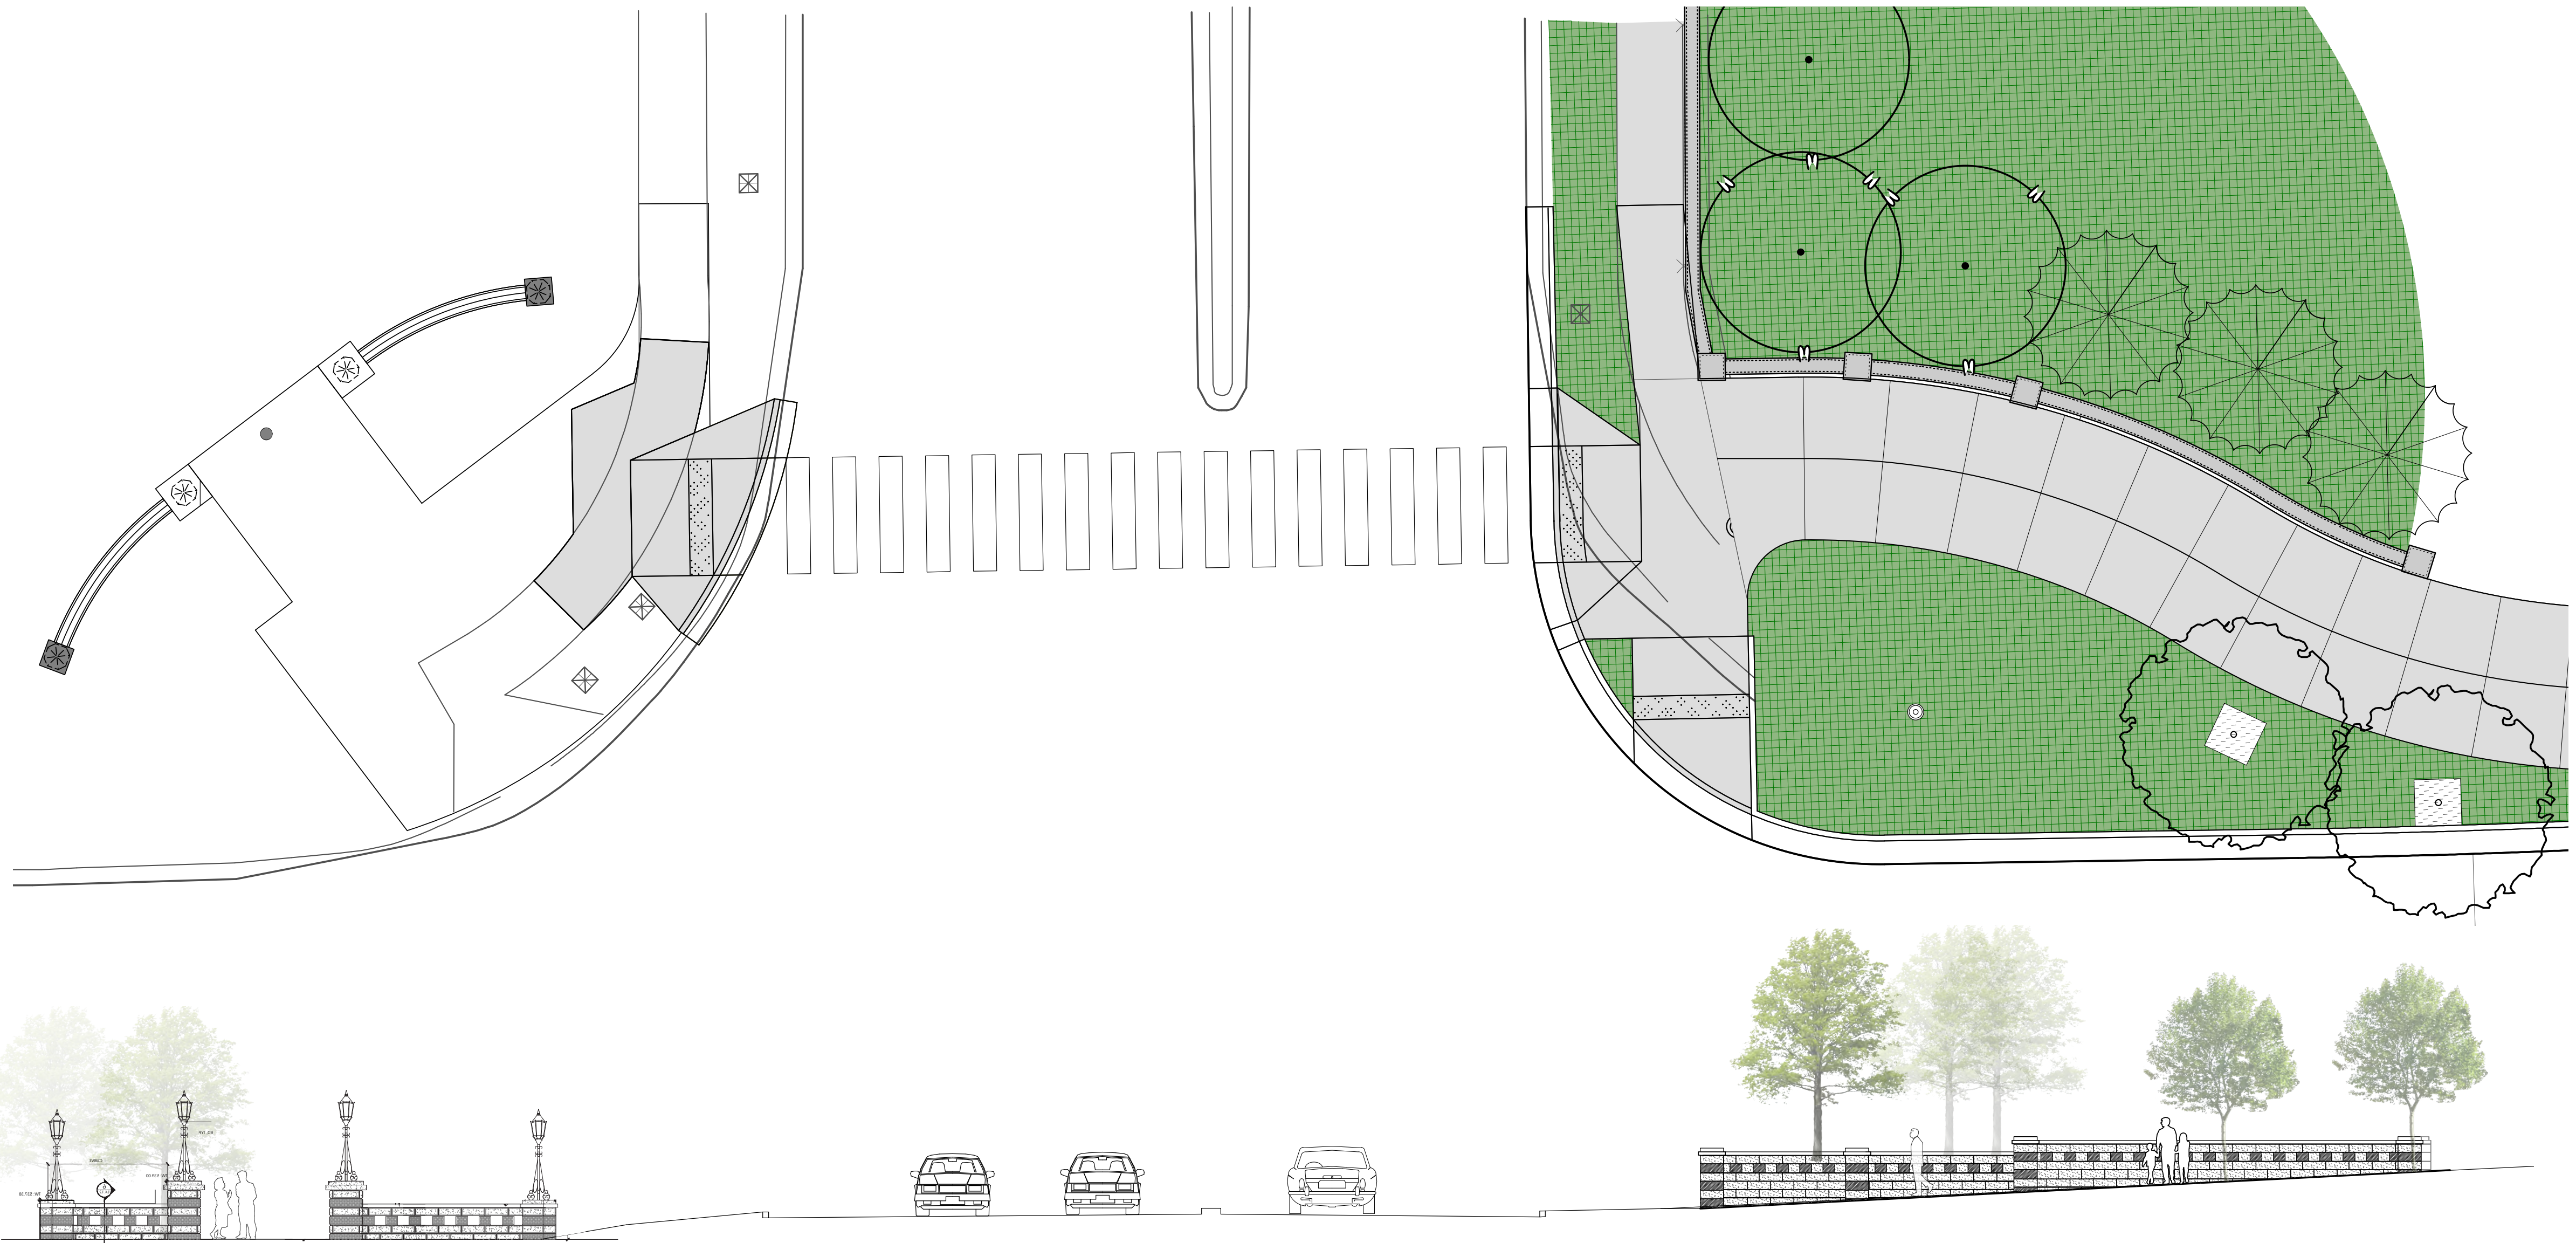



NOTE:
CONTRACTOR TO MATCH THE PRECAST
PANELS USED FOR CENTENNIAL
PARK MONUMENT WALLS.

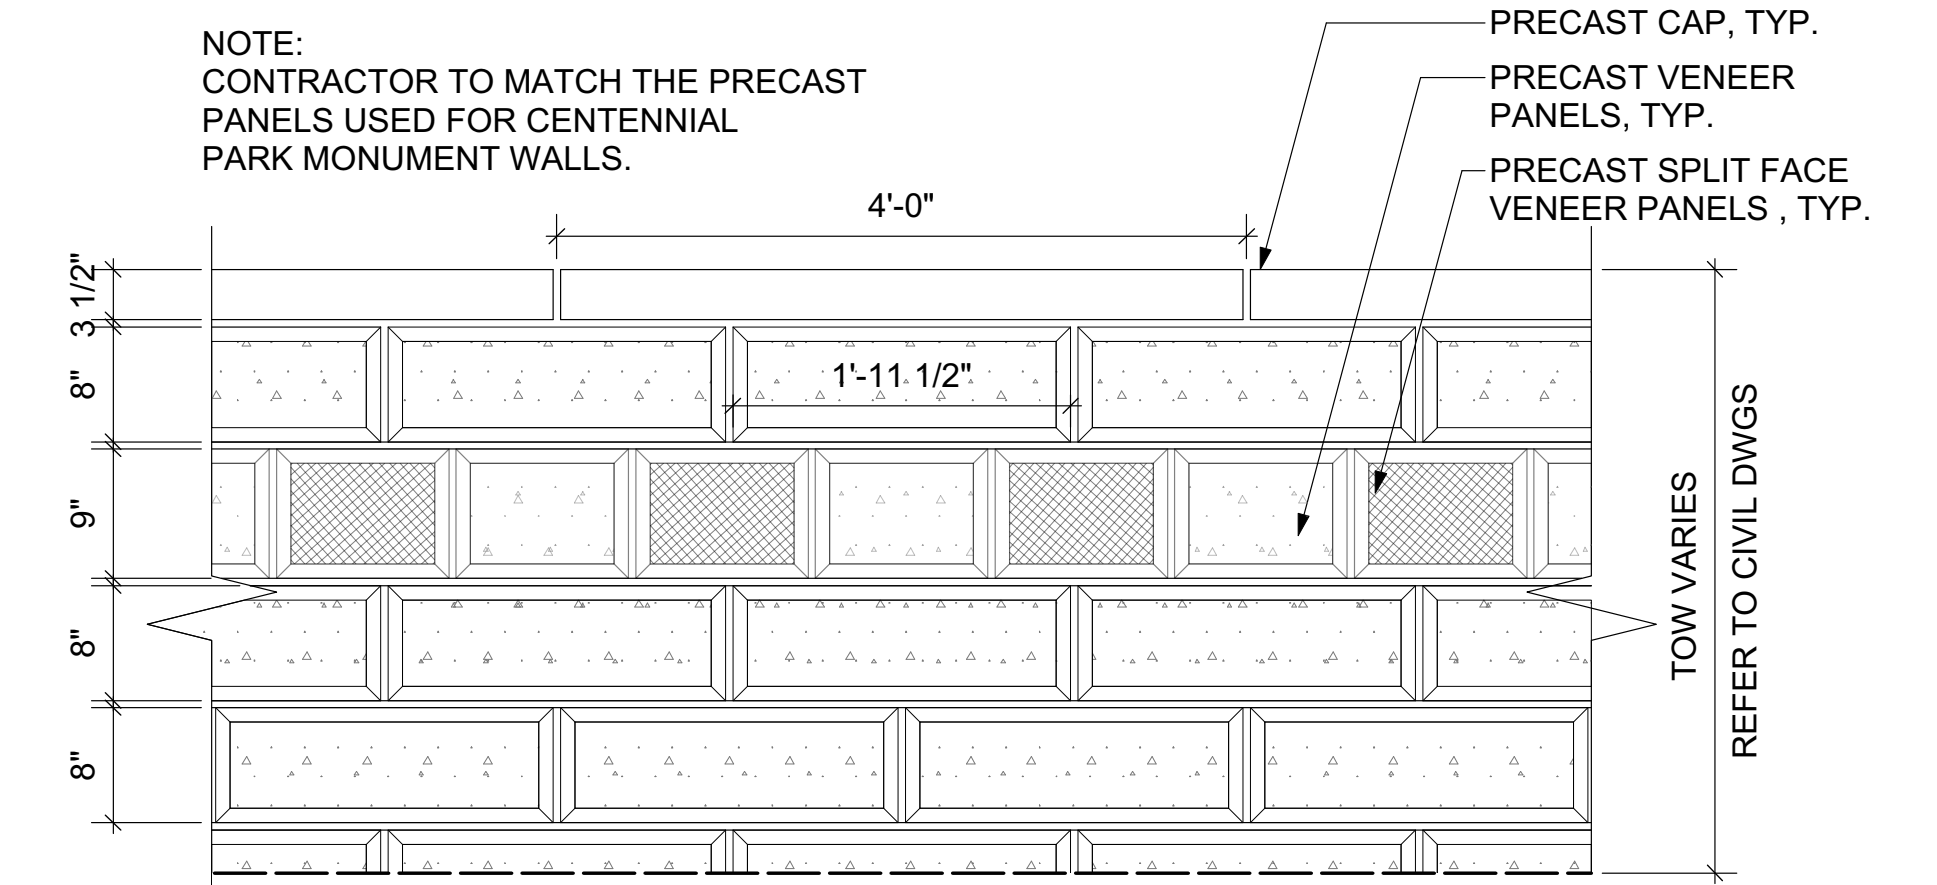

1 ELEVATION: RETAINING WALL TYP.
Scale: 1" = 1'-0"

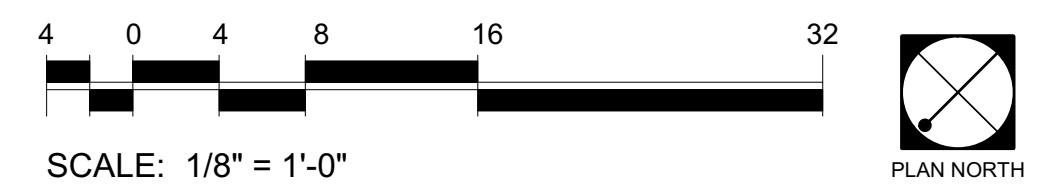

EXISTING CENTENNIAL PARK WALLS

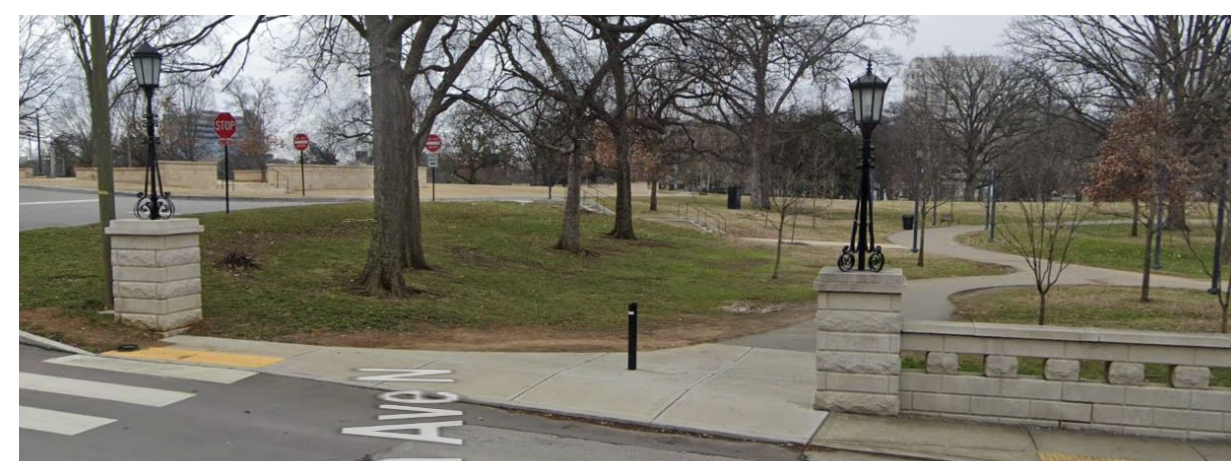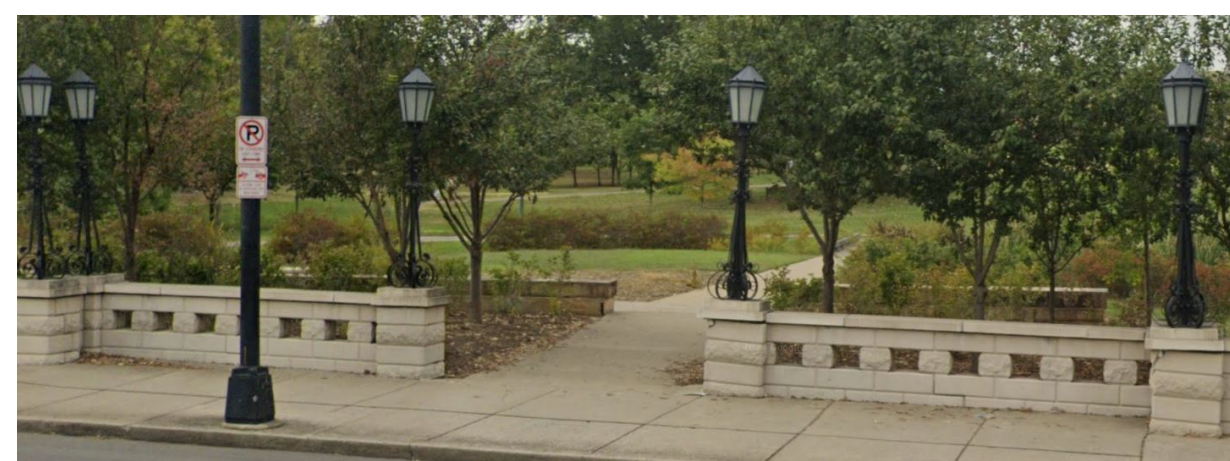

Retaining Wall Elevation

Exhibit

